


BOYATTPLANS.COM

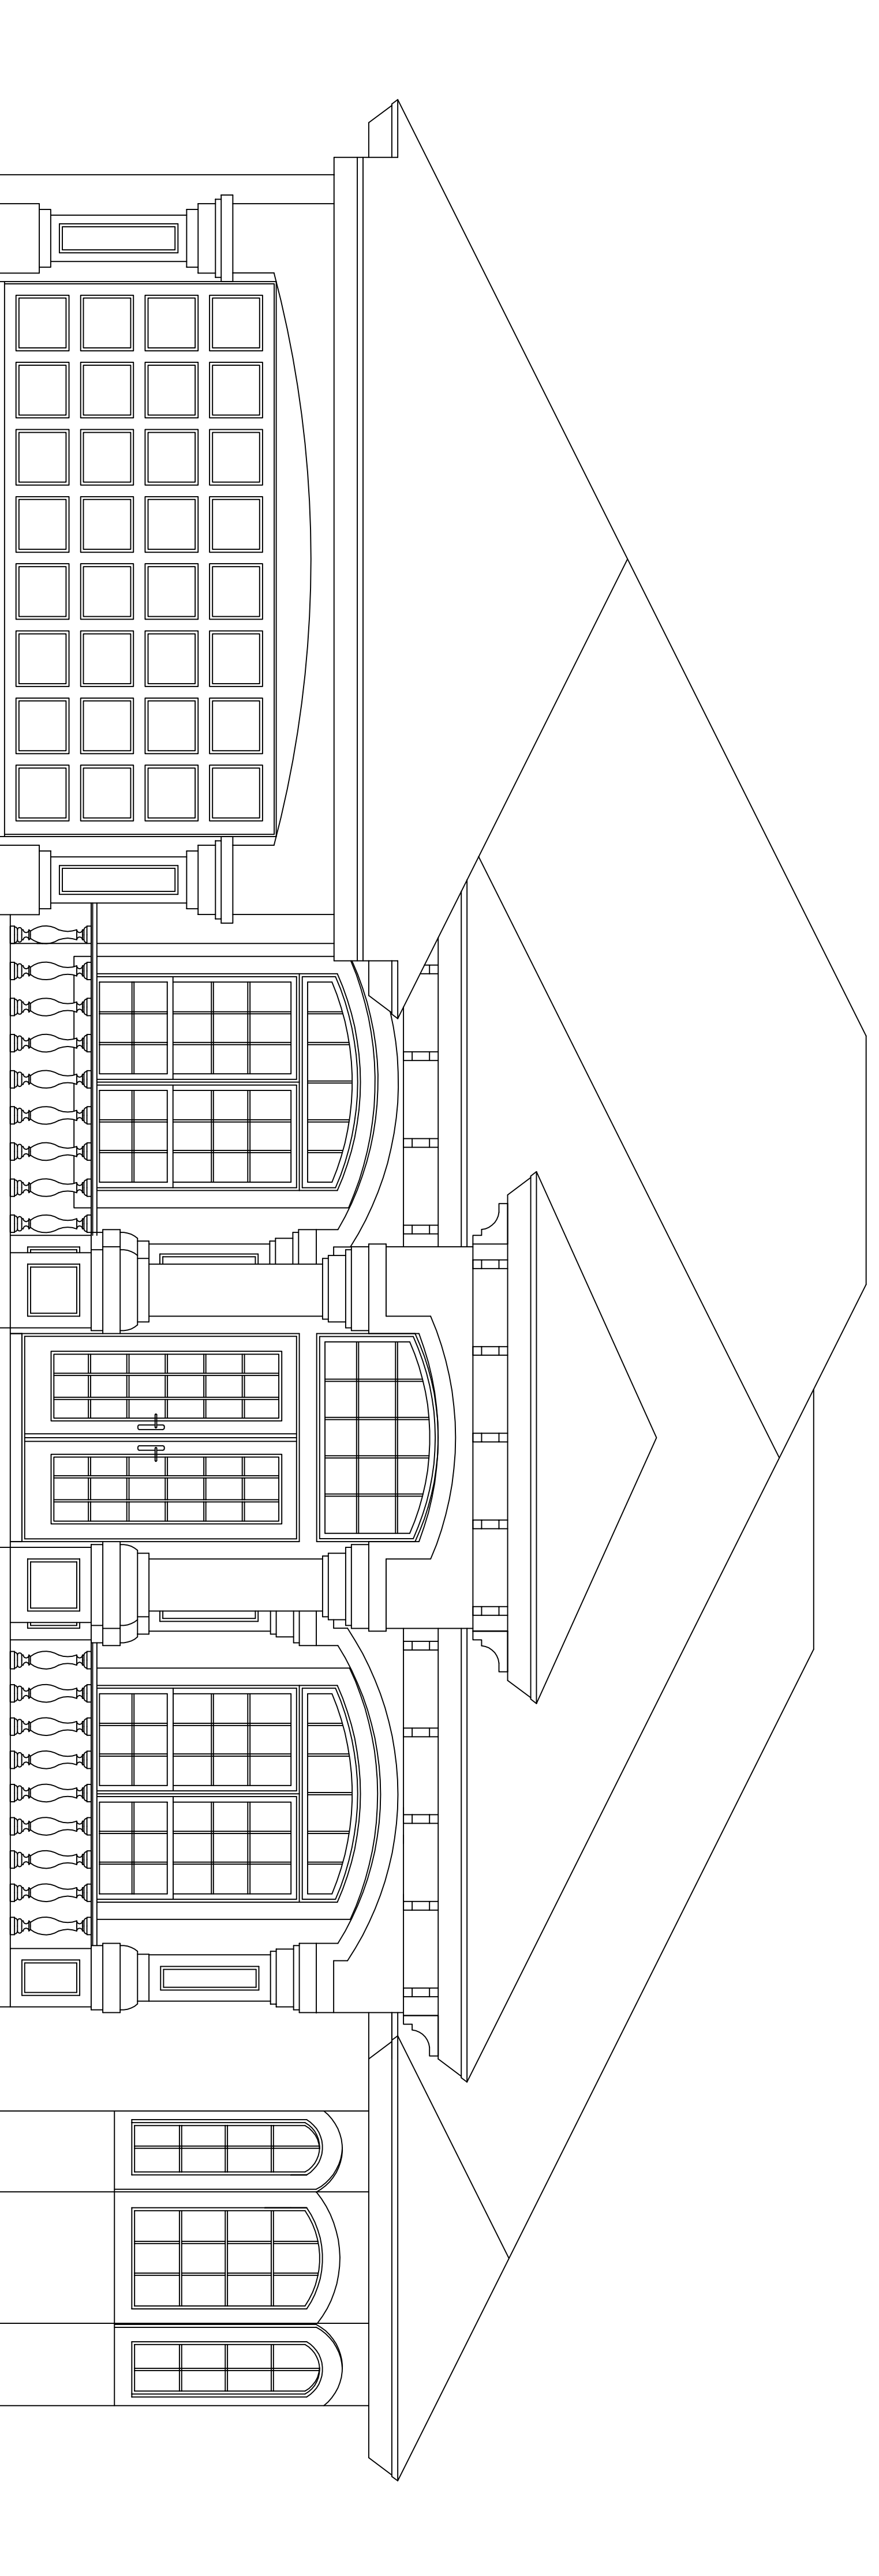

© COPYRIGHT BOYATTPLANS.COM

VILLA DE PALERMO

PLAN NO: BGH-1001-2

COPYRIGHT NOTICE

ALL RIGHTS RESERVED. THIS DRAWING IS THE PROPERTY OF BOYATTPLANS.COM. ANY REPRODUCTION, DISTRIBUTION, OR TRANSMISSION OF THIS DRAWING IN ANY FORM OR BY ANY MEANS, WITHOUT THE WRITTEN PERMISSION OF BOYATTPLANS.COM, IS STRICTLY PROHIBITED. BOYATTPLANS.COM AND ITS DESIGNERS ASSUME NO LIABILITY FOR ANY DAMAGES, INCLUDING STRUCTURAL FAILURES, RESULTING FROM THE USE OF THESE DRAWINGS. THE USER OF THESE DRAWINGS SHALL BE RESPONSIBLE FOR OBTAINING ALL NECESSARY PERMITS AND APPROVALS FROM LOCAL, STATE, AND FEDERAL AUTHORITIES. BOYATTPLANS.COM AND ITS DESIGNERS SHALL NOT BE HELD RESPONSIBLE FOR ANY DAMAGES, INCLUDING ATTORNEY FEES, DAMAGES, AND LOSS OF PROFITS, ARISING FROM THE USE OF THESE DRAWINGS. SPECIAL NOTE: COPYRIGHT LICENSE RELEASE FORM IS NONTRANSFERABLE FROM ITS ORIGINAL SIGNER(S).

THESE PLANS ARE TO BE CONSIDERED AS CONFIDENTIAL ARCHITECTURAL DRAWINGS ONLY AND SHALL NOT BE CONSTRUED AS A FINAL SET OF ENGINEERED DOCUMENTS FOR CONSTRUCTION PURPOSES. IT SHALL BE THE RESPONSIBILITY OF THE ARCHITECT, ENGINEER, CERTIFIED DESIGNER, AND/OR GENERAL CONTRACTOR, LICENSED TO PRACTICE IN THAT JURISDICTION, TO HAVE THE DRAWINGS REVIEWED BY AN ARCHITECT, ENGINEER, CERTIFIED DESIGNER, AND/OR GENERAL CONTRACTOR, LICENSED TO PRACTICE IN THAT JURISDICTION, TO DETERMINE THE NECESSARY INFORMATION OR ADDITIONAL DRAWINGS (IE STRUCTURAL TO INCLUDE FOUNDATION, FLOORROOF TRUSS DESIGN, MECHANICAL, PLUMBING, AND ELECTRICAL) REQUIRED FOR CONSTRUCTION AND BUILDING PERMITS. ACTUAL WALL SECTIONS AND DETAILS SHOWN ARE FOR DESIGN COORDINATION PURPOSES ONLY. EXACT WALL ROOF MATERIAL COMPOSITION AND DETAILING OF MATERIALS DETERMINED BY THE PURCHASER/OWNER OR GENERAL CONTRACTOR AT THE TIME OF CONSTRUCTION.

THESE PLANS MUST BE THOROUGHLY REVIEWED BY A LICENSED ARCHITECT, PROFESSIONAL ENGINEER, OR GENERAL CONTRACTOR LICENSED TO PRACTICE IN THE GEOGRAPHICAL AREA IN WHICH THESE PLANS WILL BE USED.

ANY REPRODUCTION OF THESE PRINTS IS PROHIBITED BY FEDERAL COPYRIGHT LAWS. ANY ILLEGAL REPRODUCTION WILL BE AGGRESSIVELY PURSUED TO THE FULLEST EXTENT OF THE COPYRIGHT LAW.
©THE BOYATT GALLERY OF HOMES

DESIGNER DISCLAIMER: BOYATTPLANS.COM has put substantial care and effort into this home design and the completion of these construction drawings. However, BOYATTPLANS.COM have not been contracted to provide personal consultation, site supervision or field inspection services and have no control over the construction materials, methods, or sequencing by the builder. For these reasons, as well as the gross variations in local building codes, Boyatt Gallery of Homes assumes no responsibility for any damages, including structural failures resulting from errors or omissions in these construction drawings. We strongly recommend that you, the homeowner, have these drawings thoroughly reviewed by a licensed architect, professional engineer, certified residential designer or general contractor licensed to practice in your area, in addition to your local building officials, prior to beginning construction.

INDEX OF SHEETS

SHEET A-1	COVER PAGE
SHEET A-2	PLUMBING PLAN
SHEET A-3	NOTE PLAN
SHEET A-4	DIMENSION PLAN
SHEET A-5	ROOF PLAN
SHEET A-6	ELEVATIONS
SHEET A-7	ELEVATIONS
SHEET A-8	SECTIONS & DETAILS
SHEET E-1	ELECTRICAL PLAN

THE OWNER OR CONTRACTOR FOR THE CONSTRUCTION OF THESE PLANS SHALL BE RESPONSIBLE FOR OBTAINING ALL NECESSARY PERMITS AND APPROVALS FROM LOCAL, STATE, AND FEDERAL AUTHORITIES. BOYATTPLANS.COM AND ITS DESIGNERS SHALL NOT BE HELD RESPONSIBLE FOR ANY DAMAGES, INCLUDING ATTORNEY FEES, DAMAGES, AND LOSS OF PROFITS, ARISING FROM THE USE OF THESE DRAWINGS. SPECIAL NOTE: COPYRIGHT LICENSE RELEASE FORM IS NONTRANSFERABLE FROM ITS ORIGINAL SIGNER(S).



BOYATTPLANS.COM

3387 East 1st Street Suite C
Blue Ridge, Georgia 30513
Ph. 1-866-209-0247

www.boyattplans.com

PLANS DESIGNED BY BOYATT DESIGN CORP.

PLAN NAME:
VILLA DE
PALERMO

PLAN NUMBER:
BGH-1001-2

DATE: 2004
PROJECT #: BGH-1001-2
DRAWN BY: bgn
CHECKED BY:
REVISIONS:

SHEET #
A-1